


NOTES:
 PRELIMINARY ONLY—NOT FOR CONSTRUCTION.
 ALL DIMENSIONS MUST BE FIELD VERIFIED BY CONTRACTOR AND ADJUSTED ACCORDING TO SITE CONDITIONS.
 ALL DEVICE LOCATIONS TO BE CONFIRMED ON SITE.

BRI-TECH SIGNATURE OF APPROVAL:

 ENGINEERING

REVISIONS:

NO.	DESCRIPTION	DATE

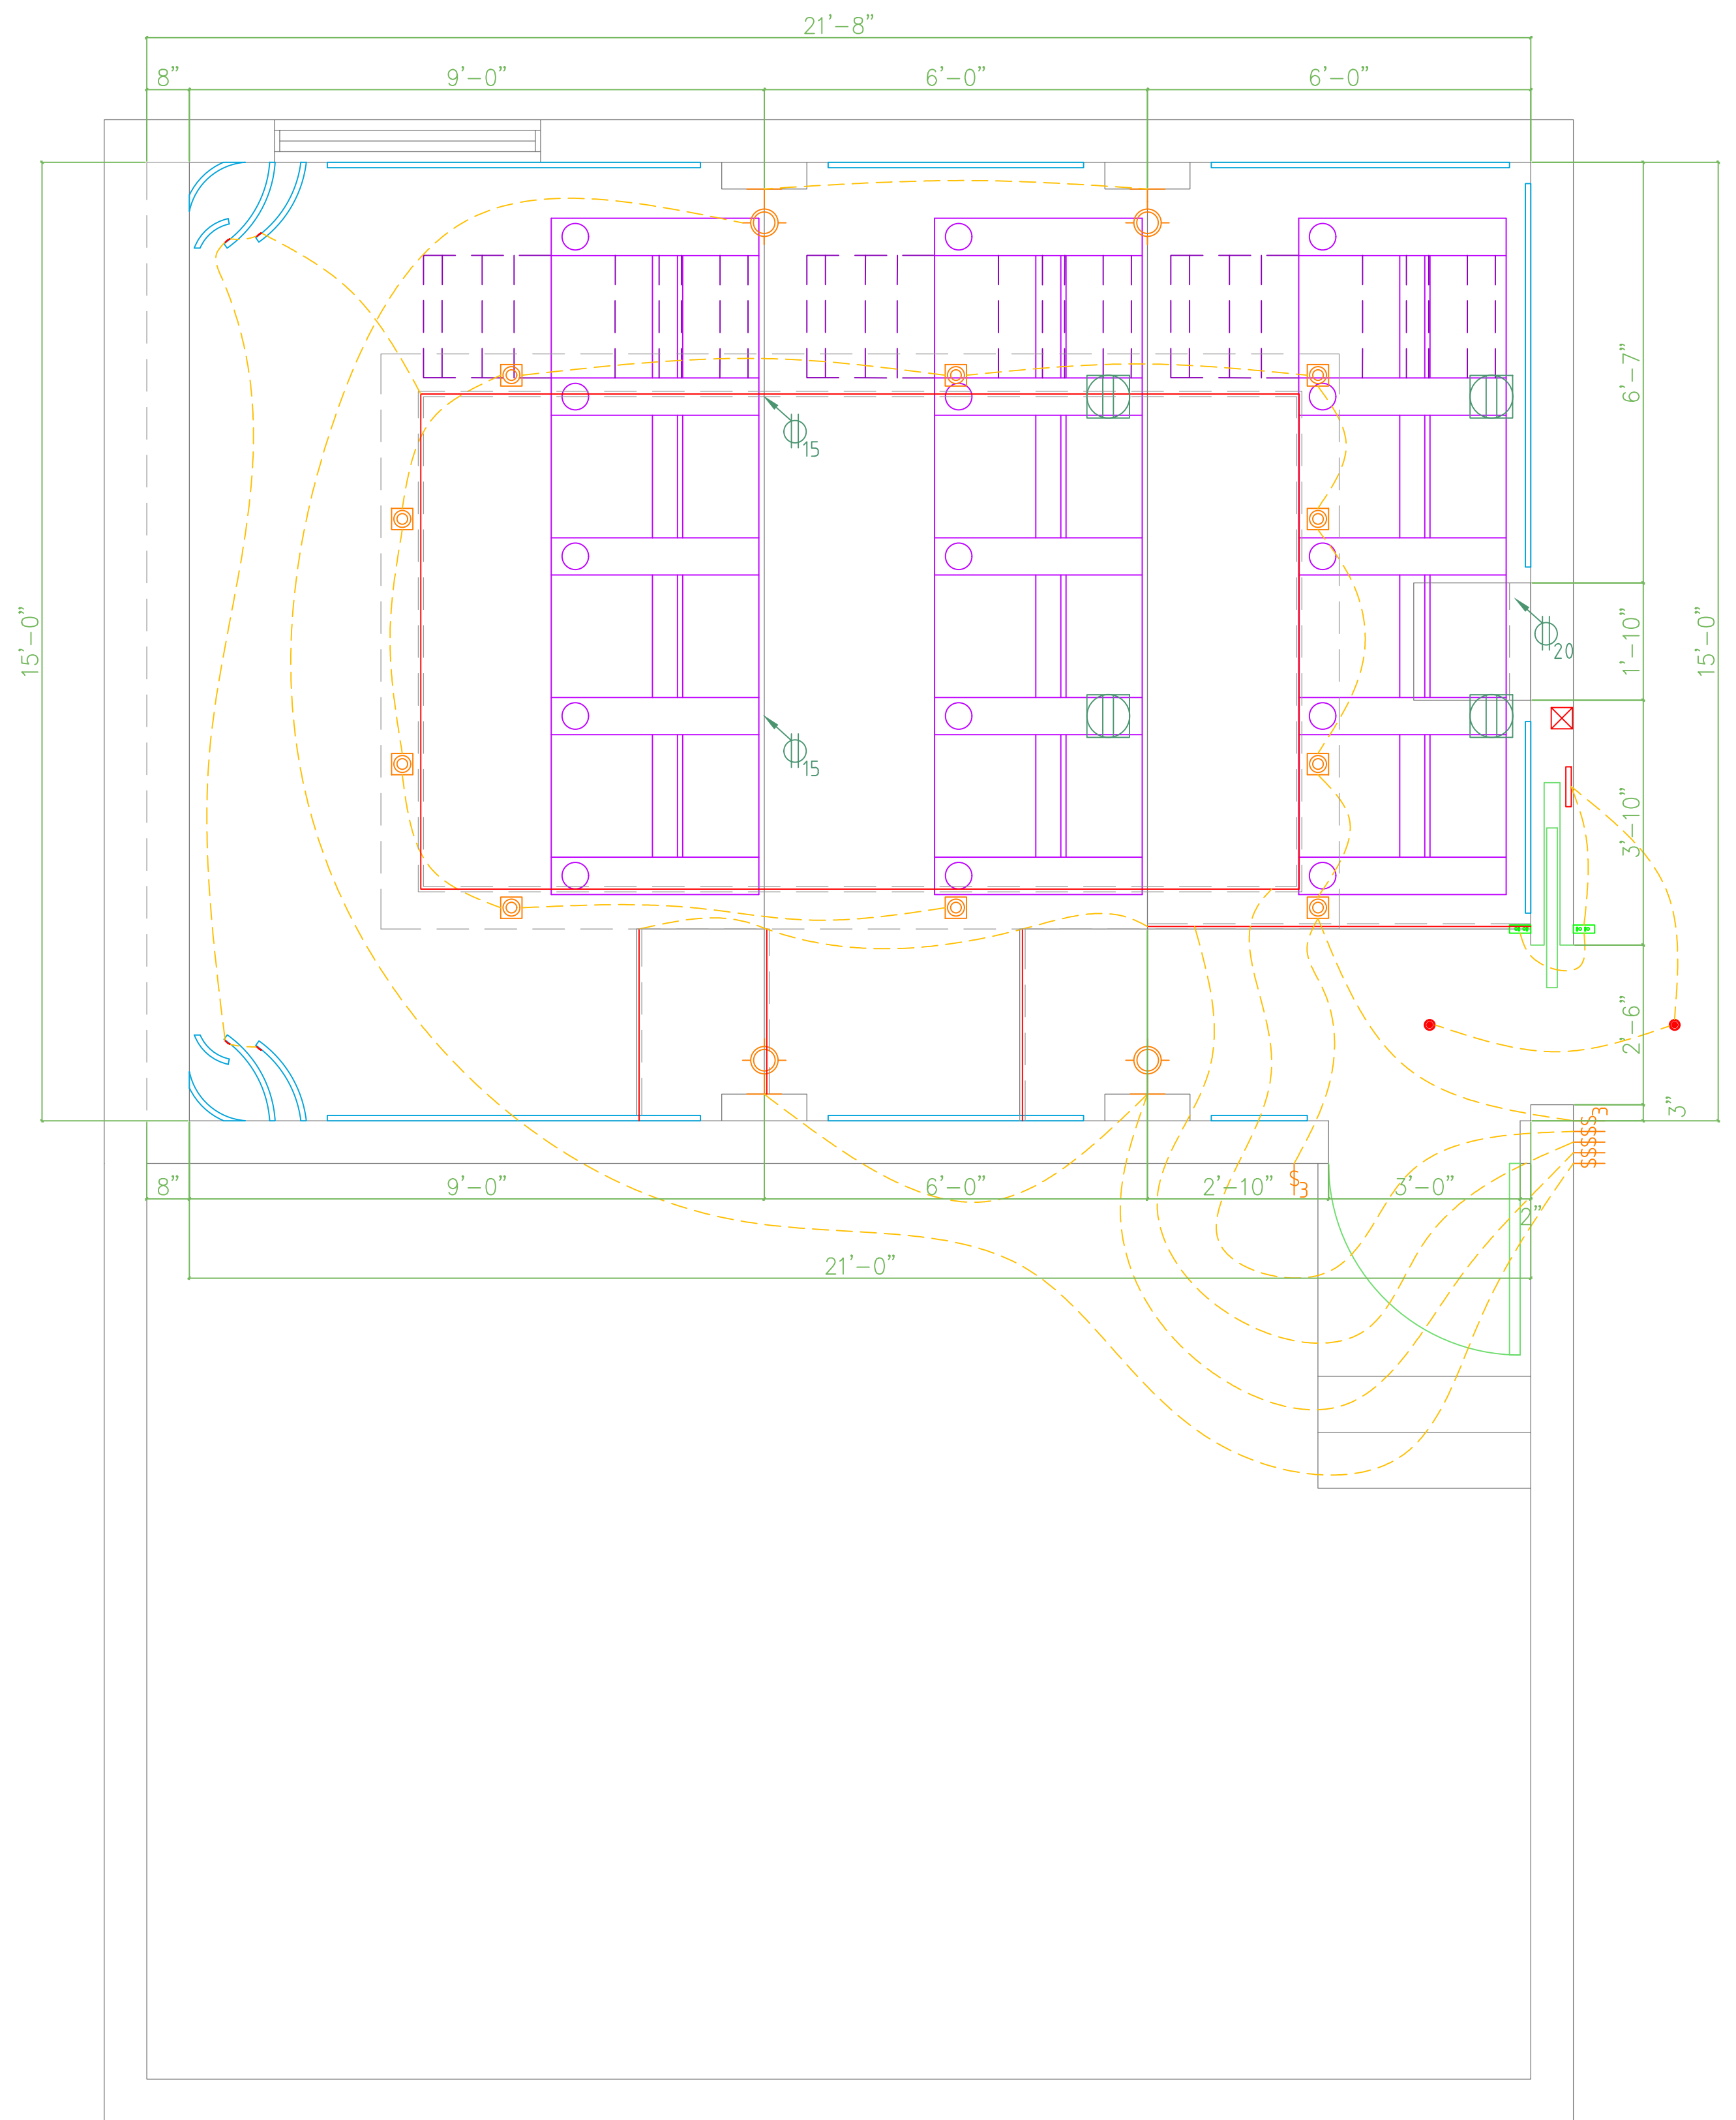

FLOOR PLAN

LIGHT FIXTURE SCHEDULE

QTY.	SYMBOL	DESCRIPTION	TYPE	MANUFACTURER	WIRE TYPE
10		RECESSED DOWNLIGHT	-	RAB	-
4		WALL SCONCE	-	-	-
-		STRIP LIGHTING	-	-	-
1		POWER RELAY (AUTOMATIC DOOR)	-	-	-
2		MOTION DETECTOR (AUTOMATIC DOOR)	-	-	-
1		CONTROLLER (AUTOMATIC DOOR)	-	-	-
2		MOTORIZED DOOR KEYPAD	-	BRI-TECH	-
4		SWITCH	-	-	-
2		3 WAY SWITCH	-	-	-

POWER EQUIPMENT SCHEDULE

QTY.	SYMBOL	DESCRIPTION	TYPE	MANUFACTURER	WIRE TYPE
1		DUPLEX 20 AMP OUTLET	-	-	-
2		DUPLEX 15 AMP OUTLET	-	-	-
4		FLOOR MOUNTED DUPLEX 15 AMP OUTLET	-	-	-

FIELD NOTES

#	DESCRIPTION
1	CUT OUTS FOR ANTICIPATED SPEAKER AND SUB LOCATIONS TO BE SPECIFIED IN FEILD

BRI-TECH
 Engineered Systems
 829 Lincoln Avenue
 Bohemia, NY 11716
 P: 631.563.8000
 F: 631.244.8005
 Bri-Tech.com

FRANCO RESIDENCE

DRAWING TITLE:
THEATER

DRAWING LOCATION:
LIGHTING CONTROL

DRAWN BY:	W.T.D	DWG. #
DATE:	08/29/2022	LC-1.0
SCALE:	3/4" = 1'-0"	
SHEET:	24" X 36"	
CHECKED BY:	BM	